


NEW UNIVERSITY COLLEGE
 APPROPRIATE
 DETAILS OF FITTINGS IN PHYSICS LECTURE ROOM
 SCALE ONE INCH = ONE FOOT AND FULL SIZE

(B) BLACKBOARDS

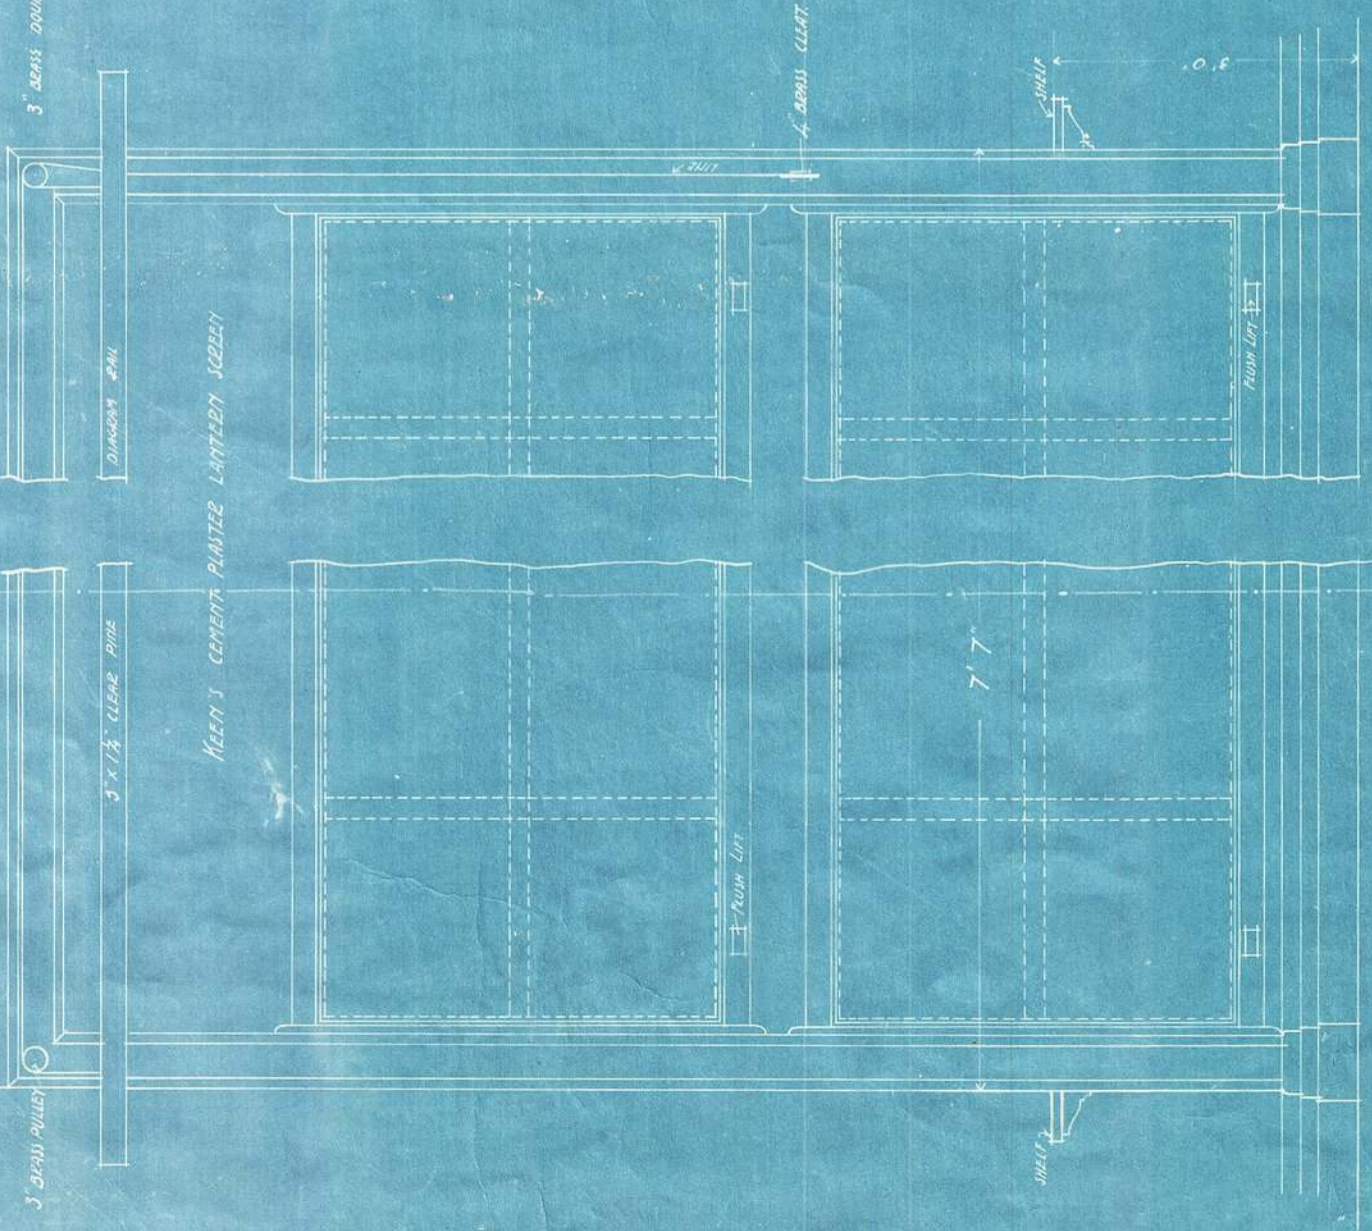


FRONT ELEVATION

-SEE SCHEDULE-



PLAN


(C) SINK

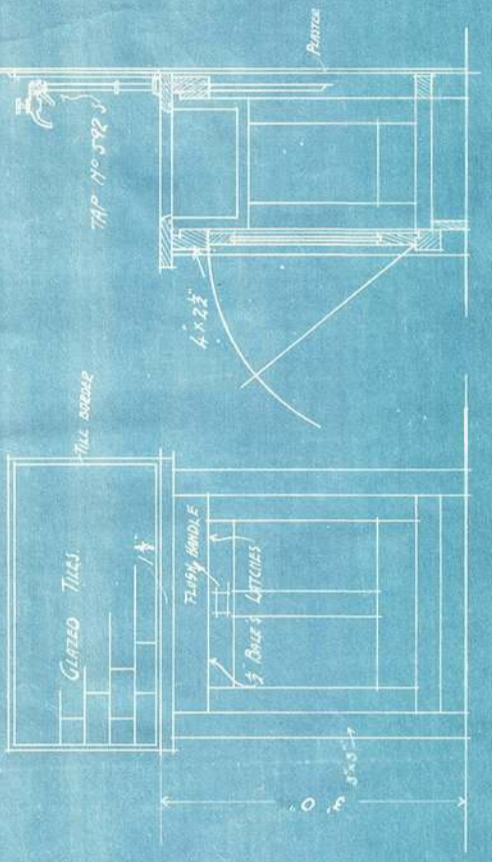

ELEVATION


SECTION

NOTE - THE EXACT DIMENSIONS OF TUB AND TAP TO BE OBTAINED FROM MANUFACTURER

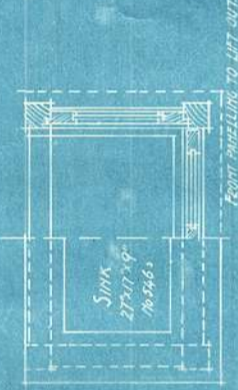


PLAN OF TOP PART OF PANELLING

(P) WALL BRACKET

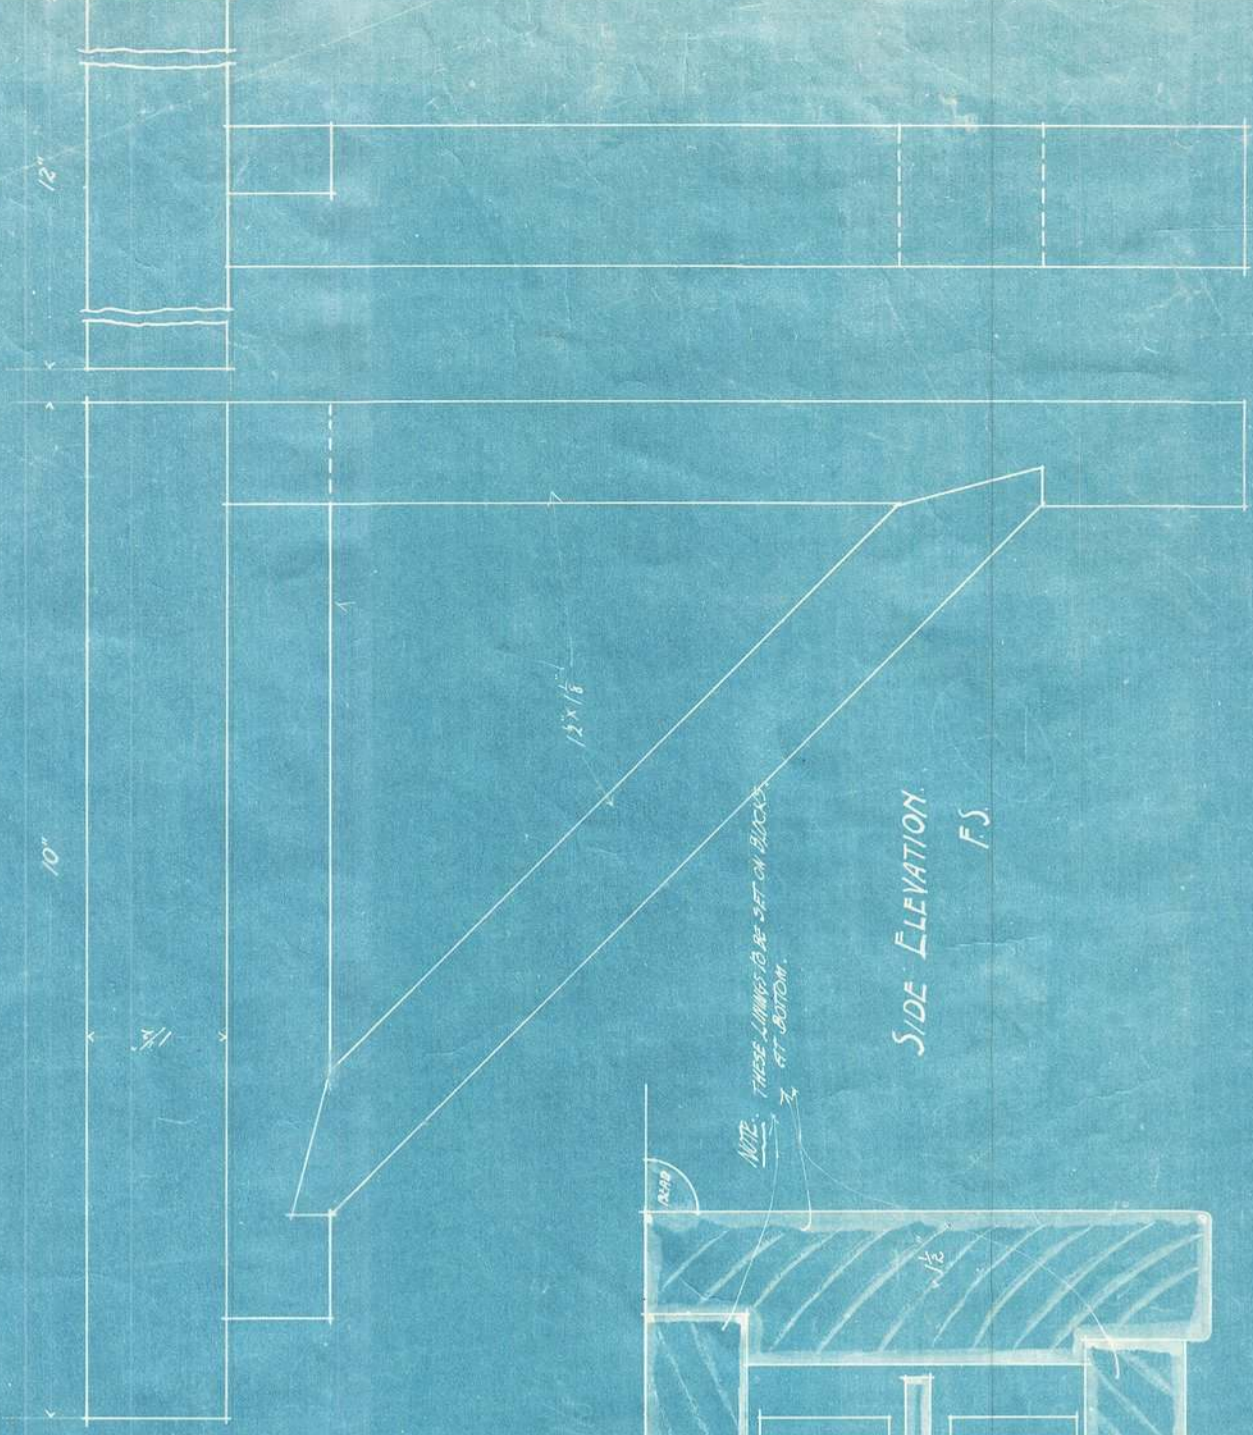

FRONT ELEVATION

FS

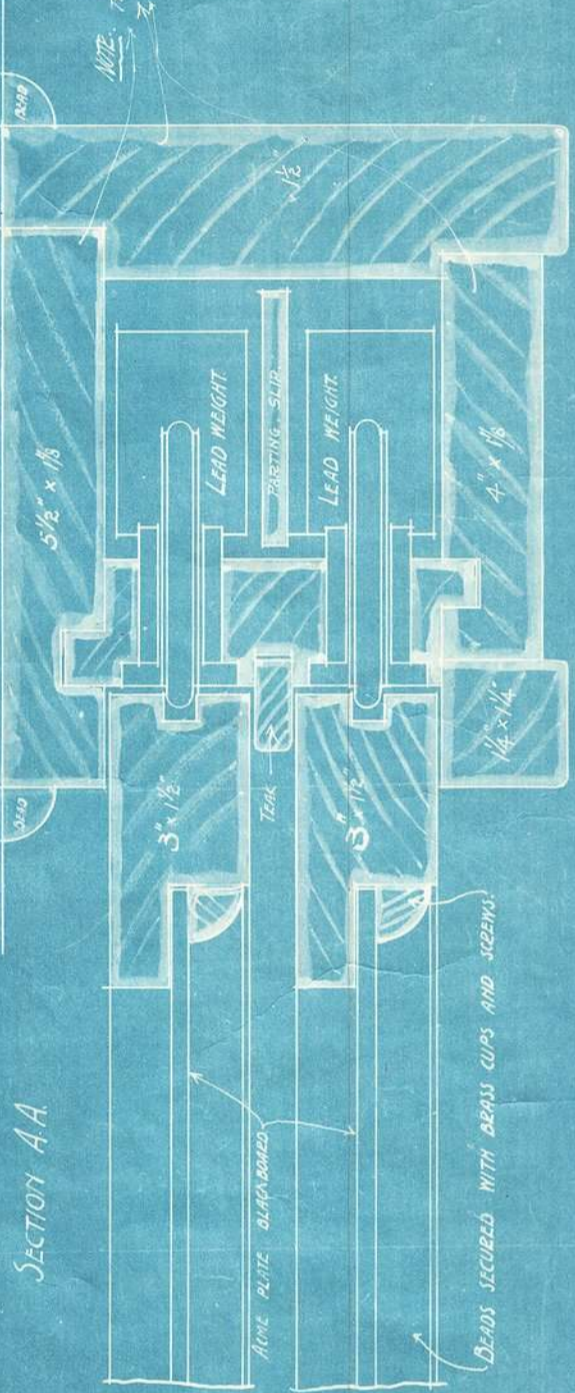

SECTION AA

FULL SIZE AT A.

BACK ELEVATION

DRAWING NO. 103/51

